 



This drawing can not be used for construction unless approved and authorized by government!

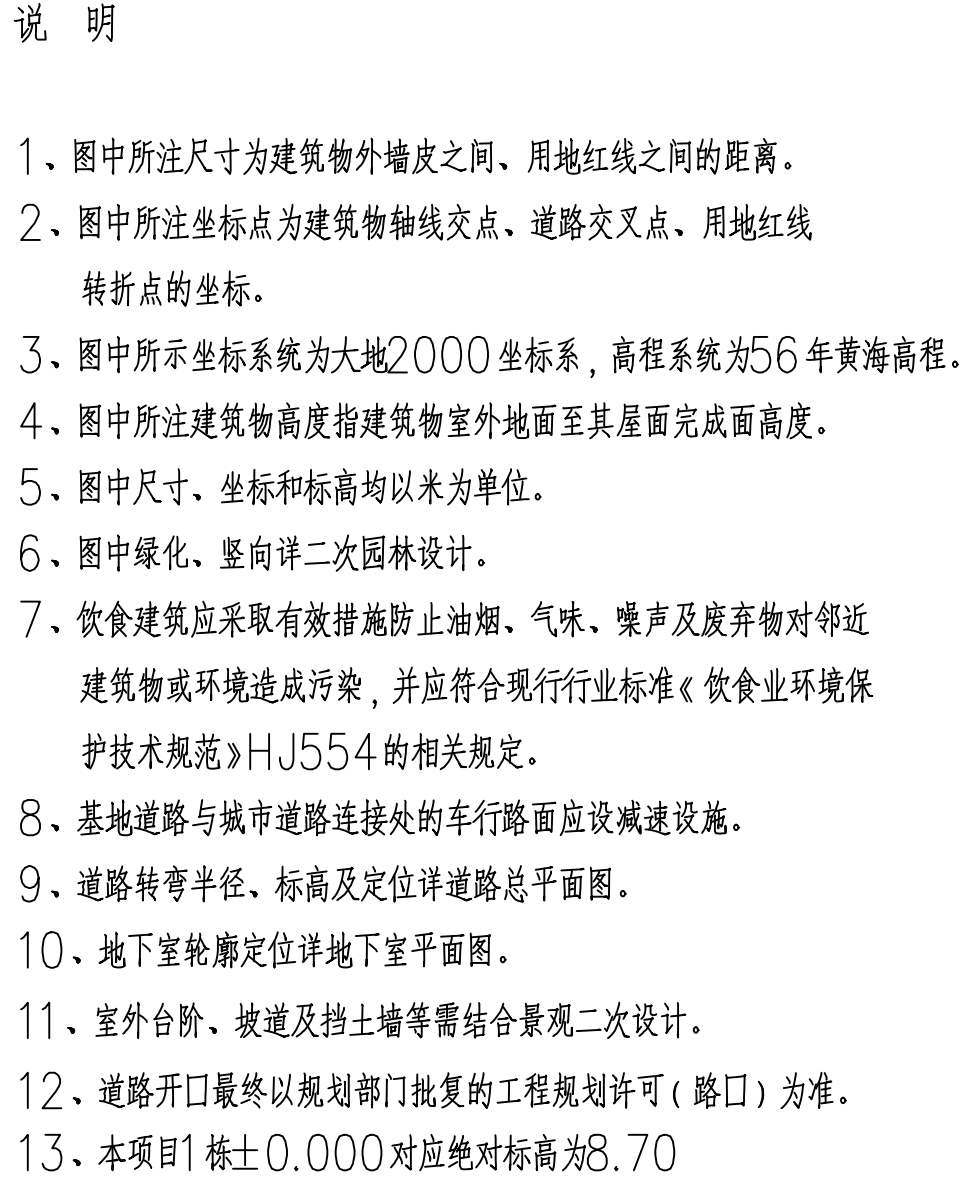

		Z H U B O D E S I G N	
		筑 博 设 计	
筑博设计股份有限公司 ZHUBO DESIGN CO., LTD.			
国家建筑工程设计证书号: A144026416 National Architectural Design License No.(Code Firm) A144026416 国家中国建筑方案设计证书号: (建) - 城规编 (14)11983 National Planning Design Certification License No.(Code Firm) (14)11983 http://www.zhubo.com			
作设计单位		CO-DESIGNER	
计总负责人 JEF ARCHITECT		修订 AMENDMENT / ISSUE REGISTER	
序号 NO.		修改内容摘要 DESCRIPTION	
结构 STRUCTURE		给排水 PLUMBING	
电气 ELECTRICAL		暖通空调 MECHANICAL	
电讯 C/ELECT			
改信息		CHANGE INFORMATION	
会签 MULTI-DISCIPLINE SIGNATURES			
总图 GOL PLAN		建筑 ARCHITECTURE	
		给排水 PLUMBING	
示意图		KEY PLAN	
位图			
设计人 DESIGNED		段彪	
校对人 CHECKED		段彪	
业务负责人 CHIEF		李昕	
业务审核人 核人		金逸群	
业务审定人 THOROUGH		梁新平	
目建筑师 EMC CHIEF		吕功云	
项目经理 PROJECT CHIEF		梁新平	
目设计号 DESIGN NO.		S15-ZB5996	
建设单位 CLIENT		深圳市易达成投资 有限公司	
项目名称 OBJECT NAME		合正湾府大厦	
子名称 PROJECT NAME			
底名称 DRAWING TITLE		屋顶总平面图	
阶段 STAGE		建设工程设计文件	
专业 CYLINE		建筑(A)	
图号 NO.		AW-01-0101	
日期 DATE		2021.11.9	
版次 REV.		RO	
目录序号 NUMBER			